


Existing foul manhole & connection point for salt water and portable water connection

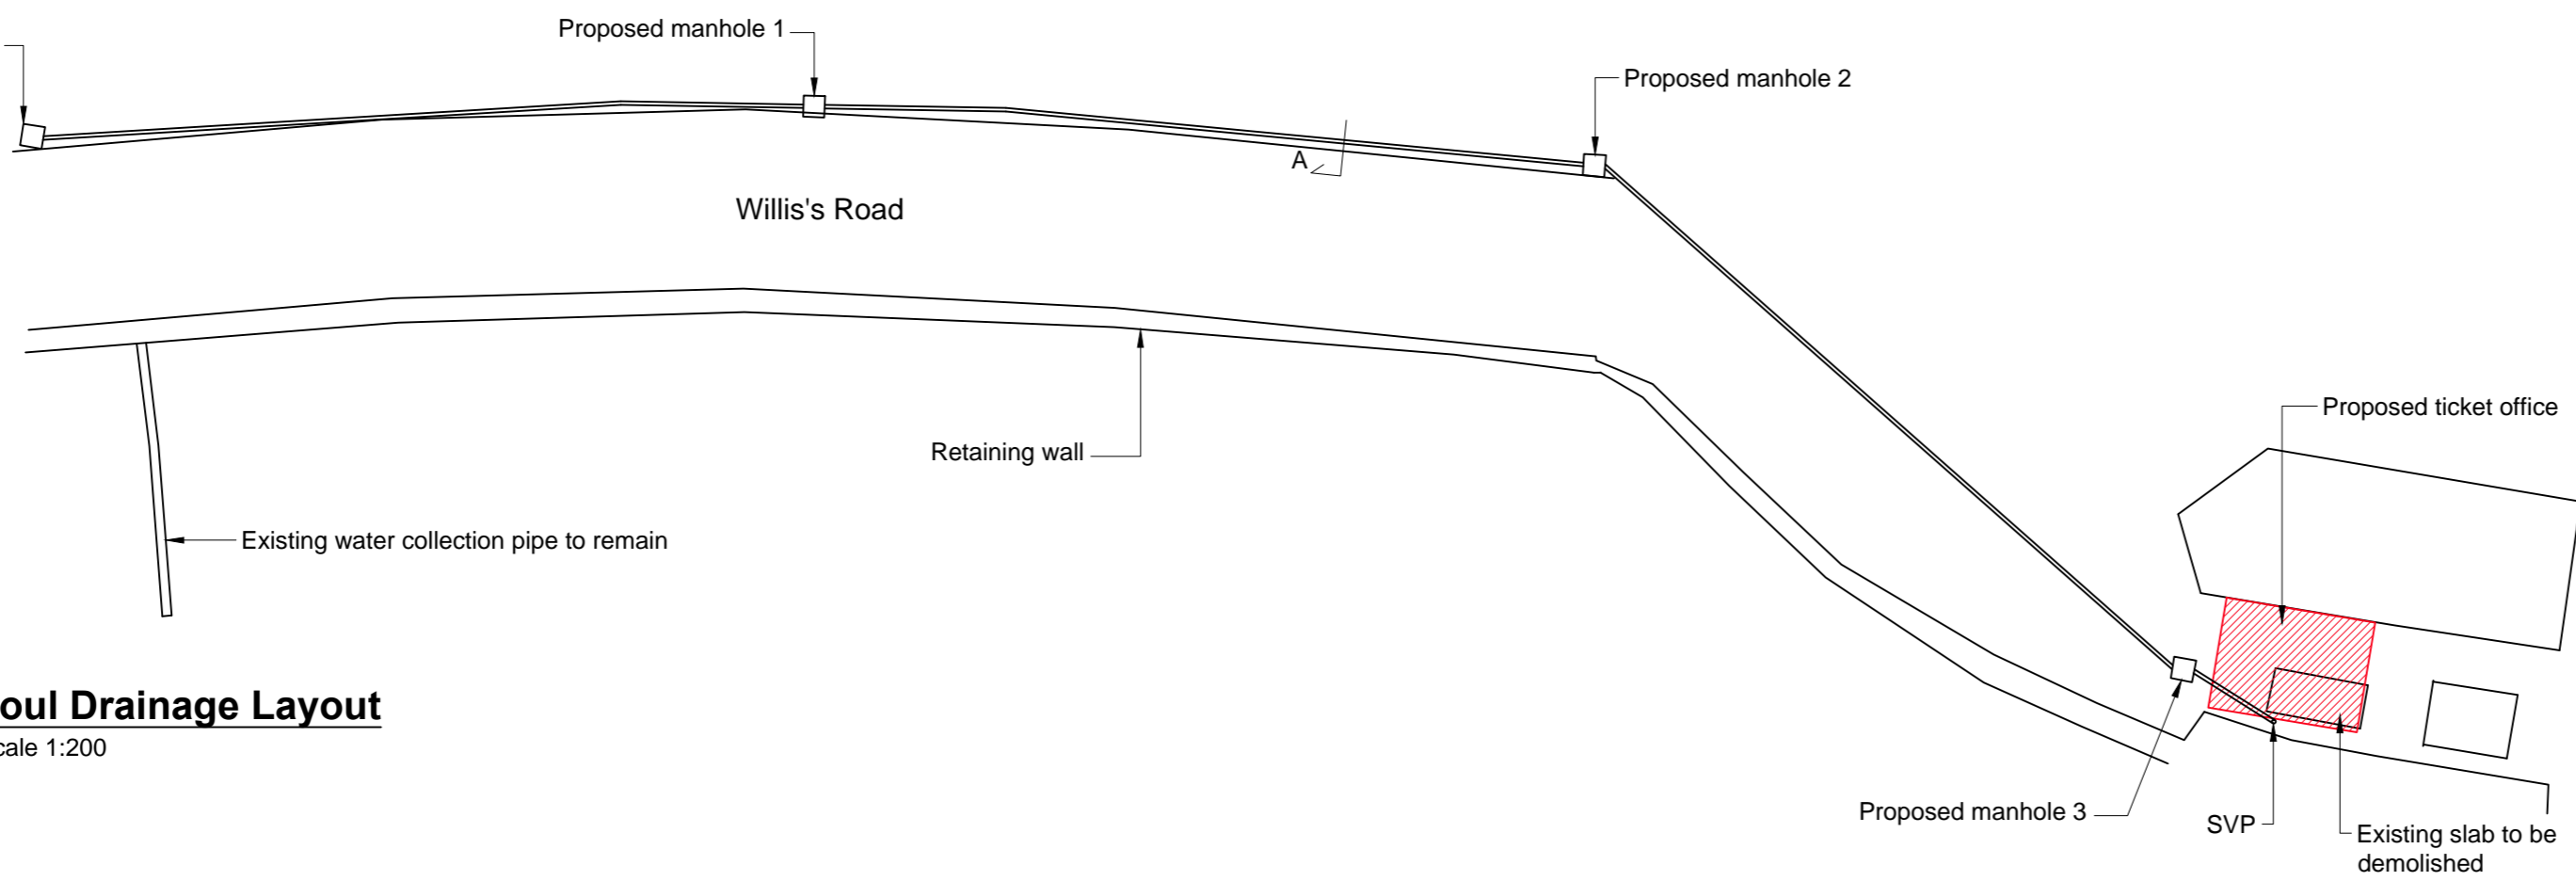

Foul Drainage Layout

Scale 1:200

NOTES:
ALL DIMENSIONS MUST BE CHECKED ON SITE AND NOT SCALED FROM THIS DRAWING.

A	Date	Revision

Government of Gibraltar
Technical Services Department
Joshua Hassan House
Secretary's Lane
Gibraltar


Job Title
**Gibraltar Tourist Board
City Under Siege
Ticket Office**

DRAWING TITLE
**Foul Drainage Layout
and Elevation**

Scale
As shown


Date 05/11/2013 Drawn by *K.A. Galliano*

Drg. No. **212/44/JB14/13/C01** Rev.

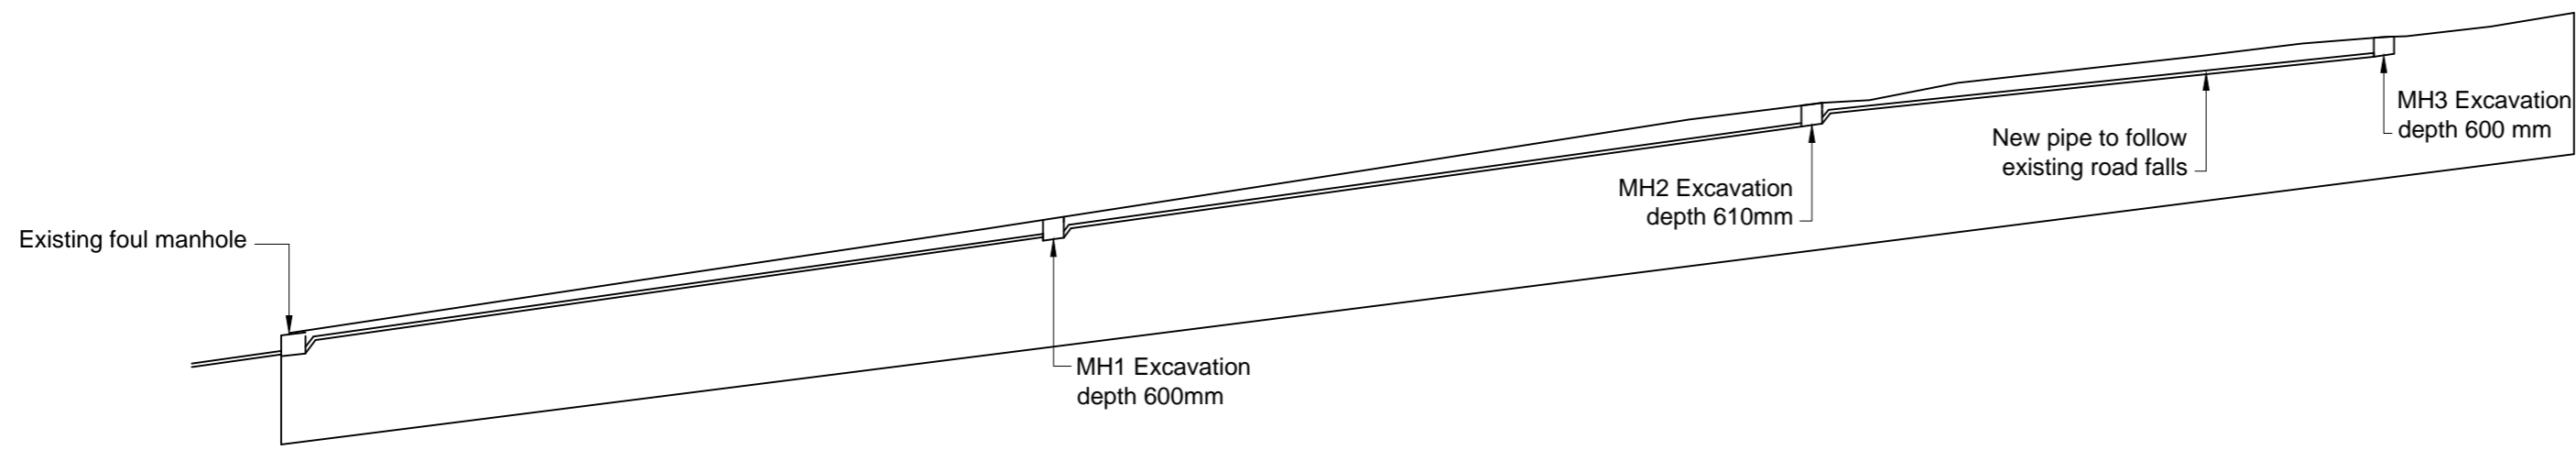

Foul Sewer Arrangement Elevation

Scale 1:200

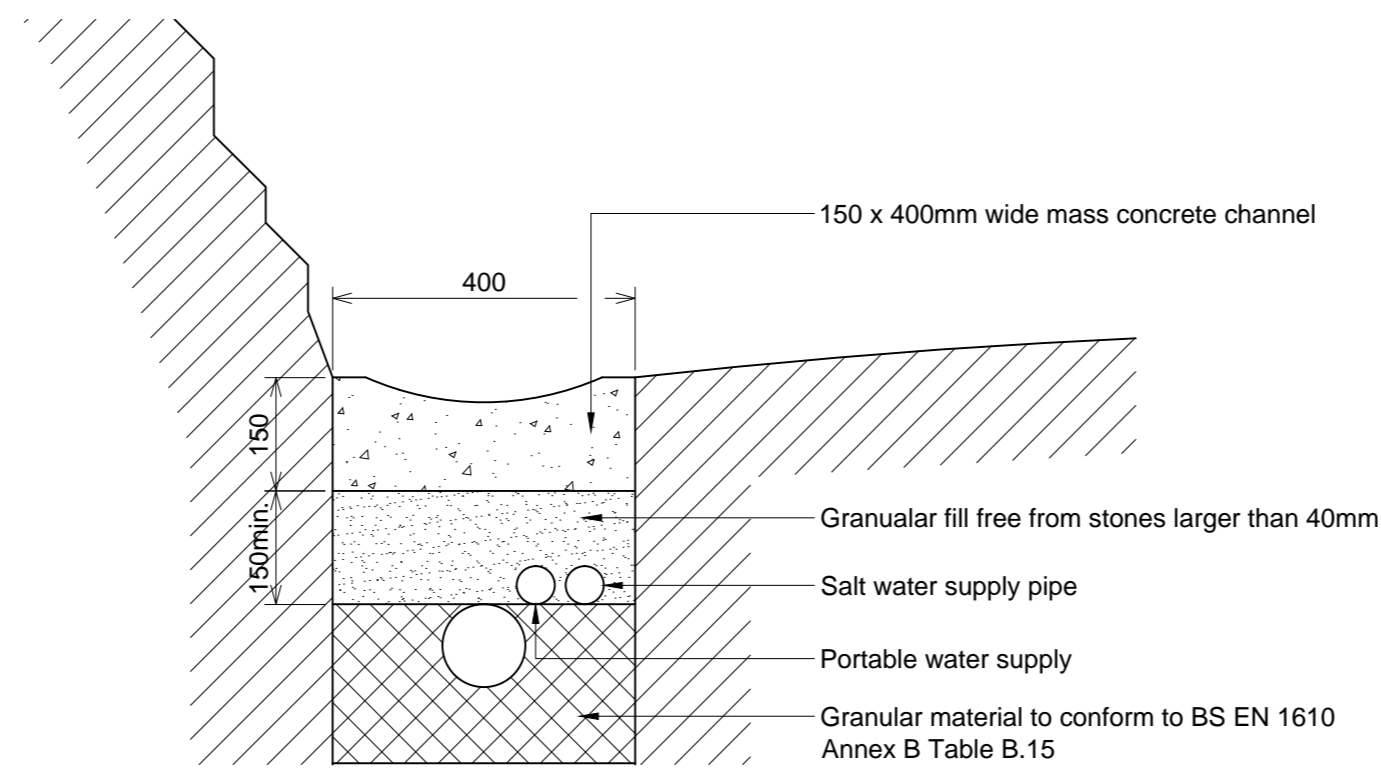

Section A (Typical)

Scale 1:10